




NO.	DESCRIPTION	DATE

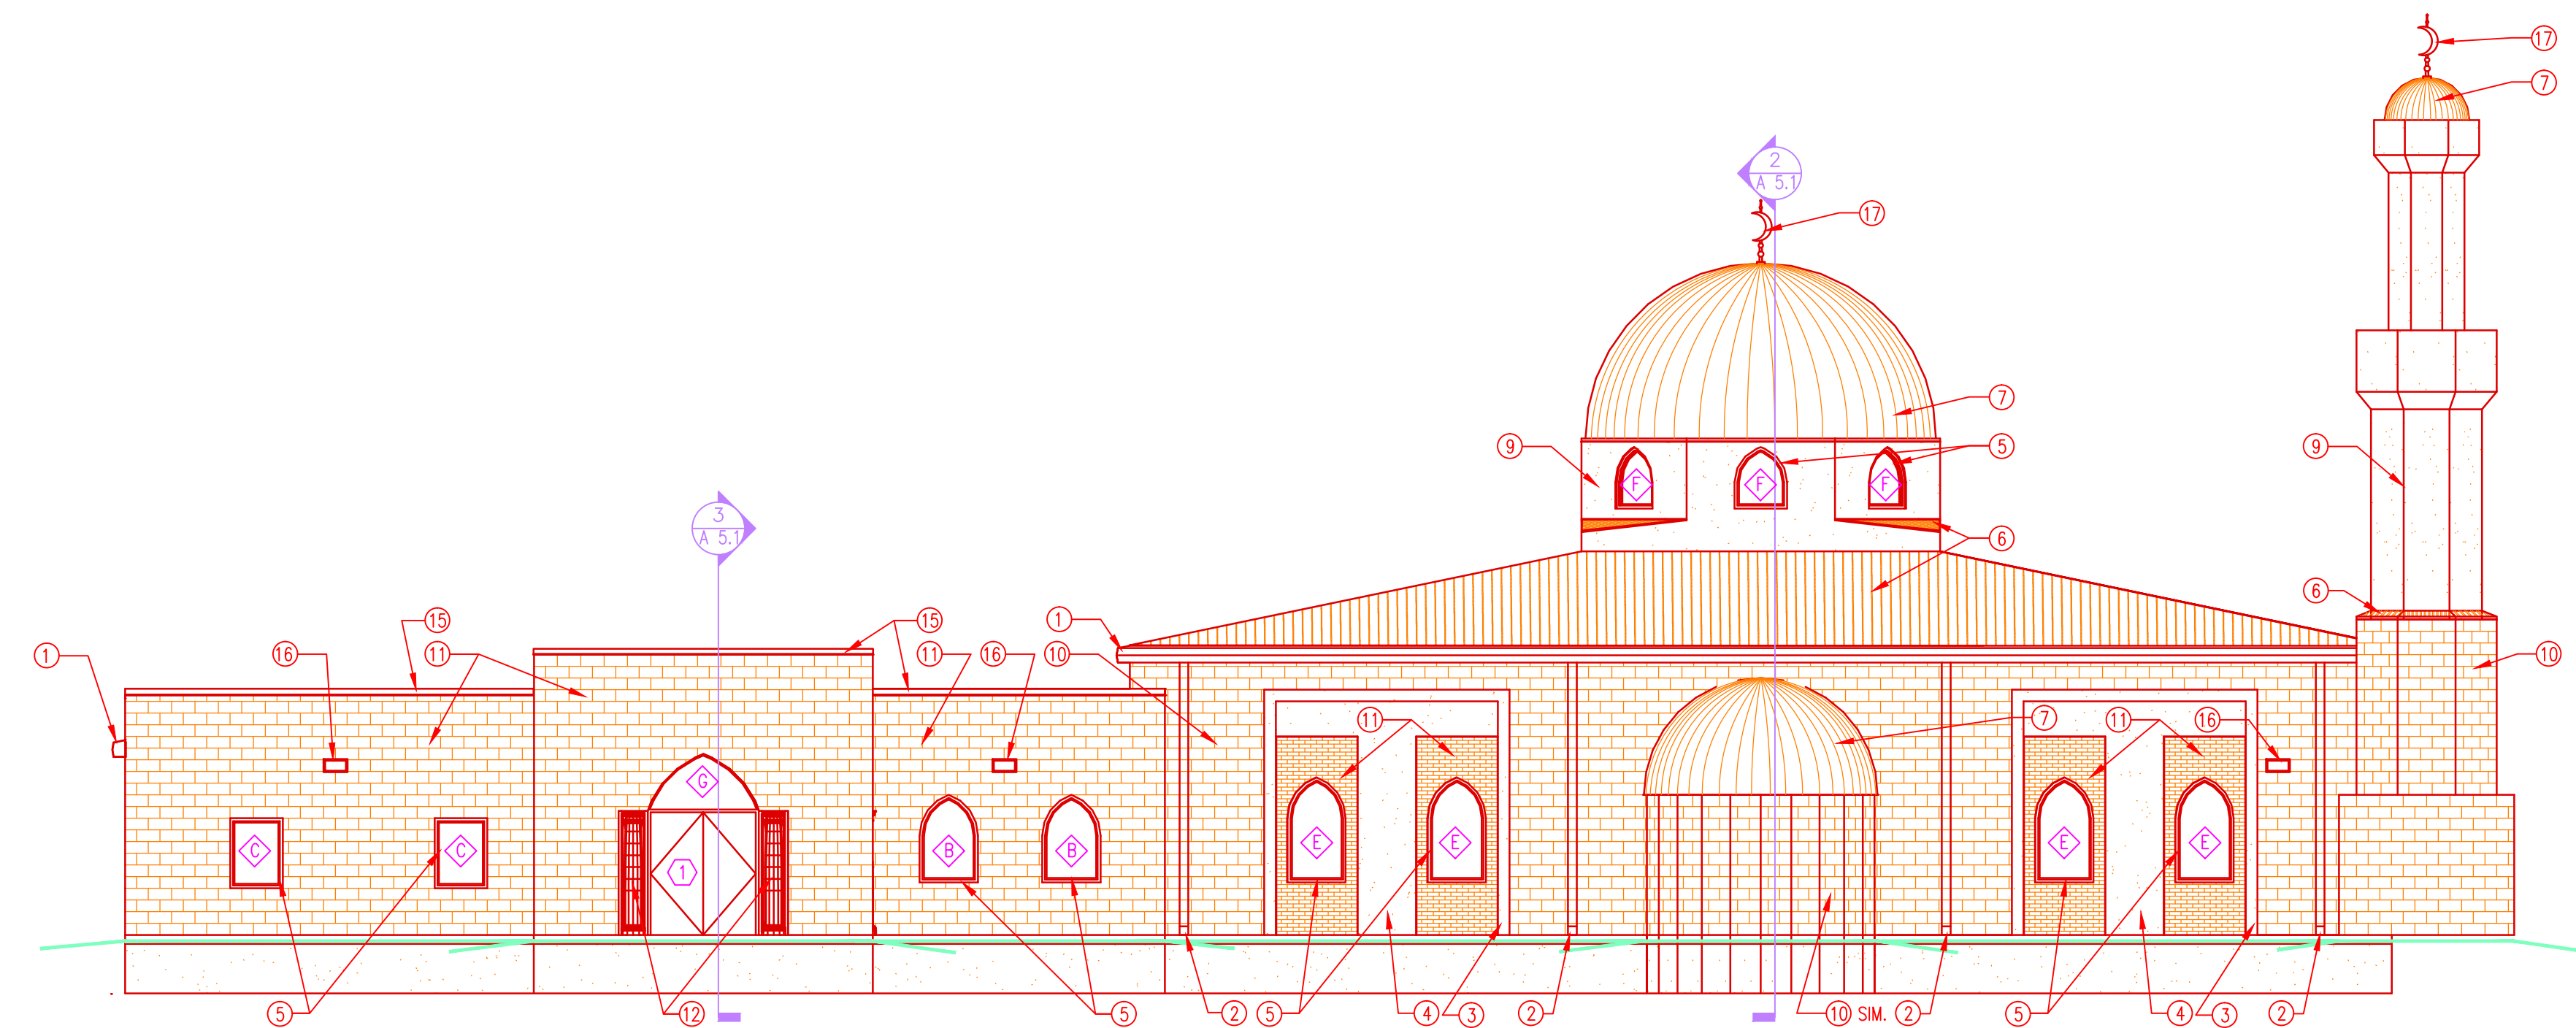


1 NORTH ELEVATION
SCALE: 1/8" = 1'-0"

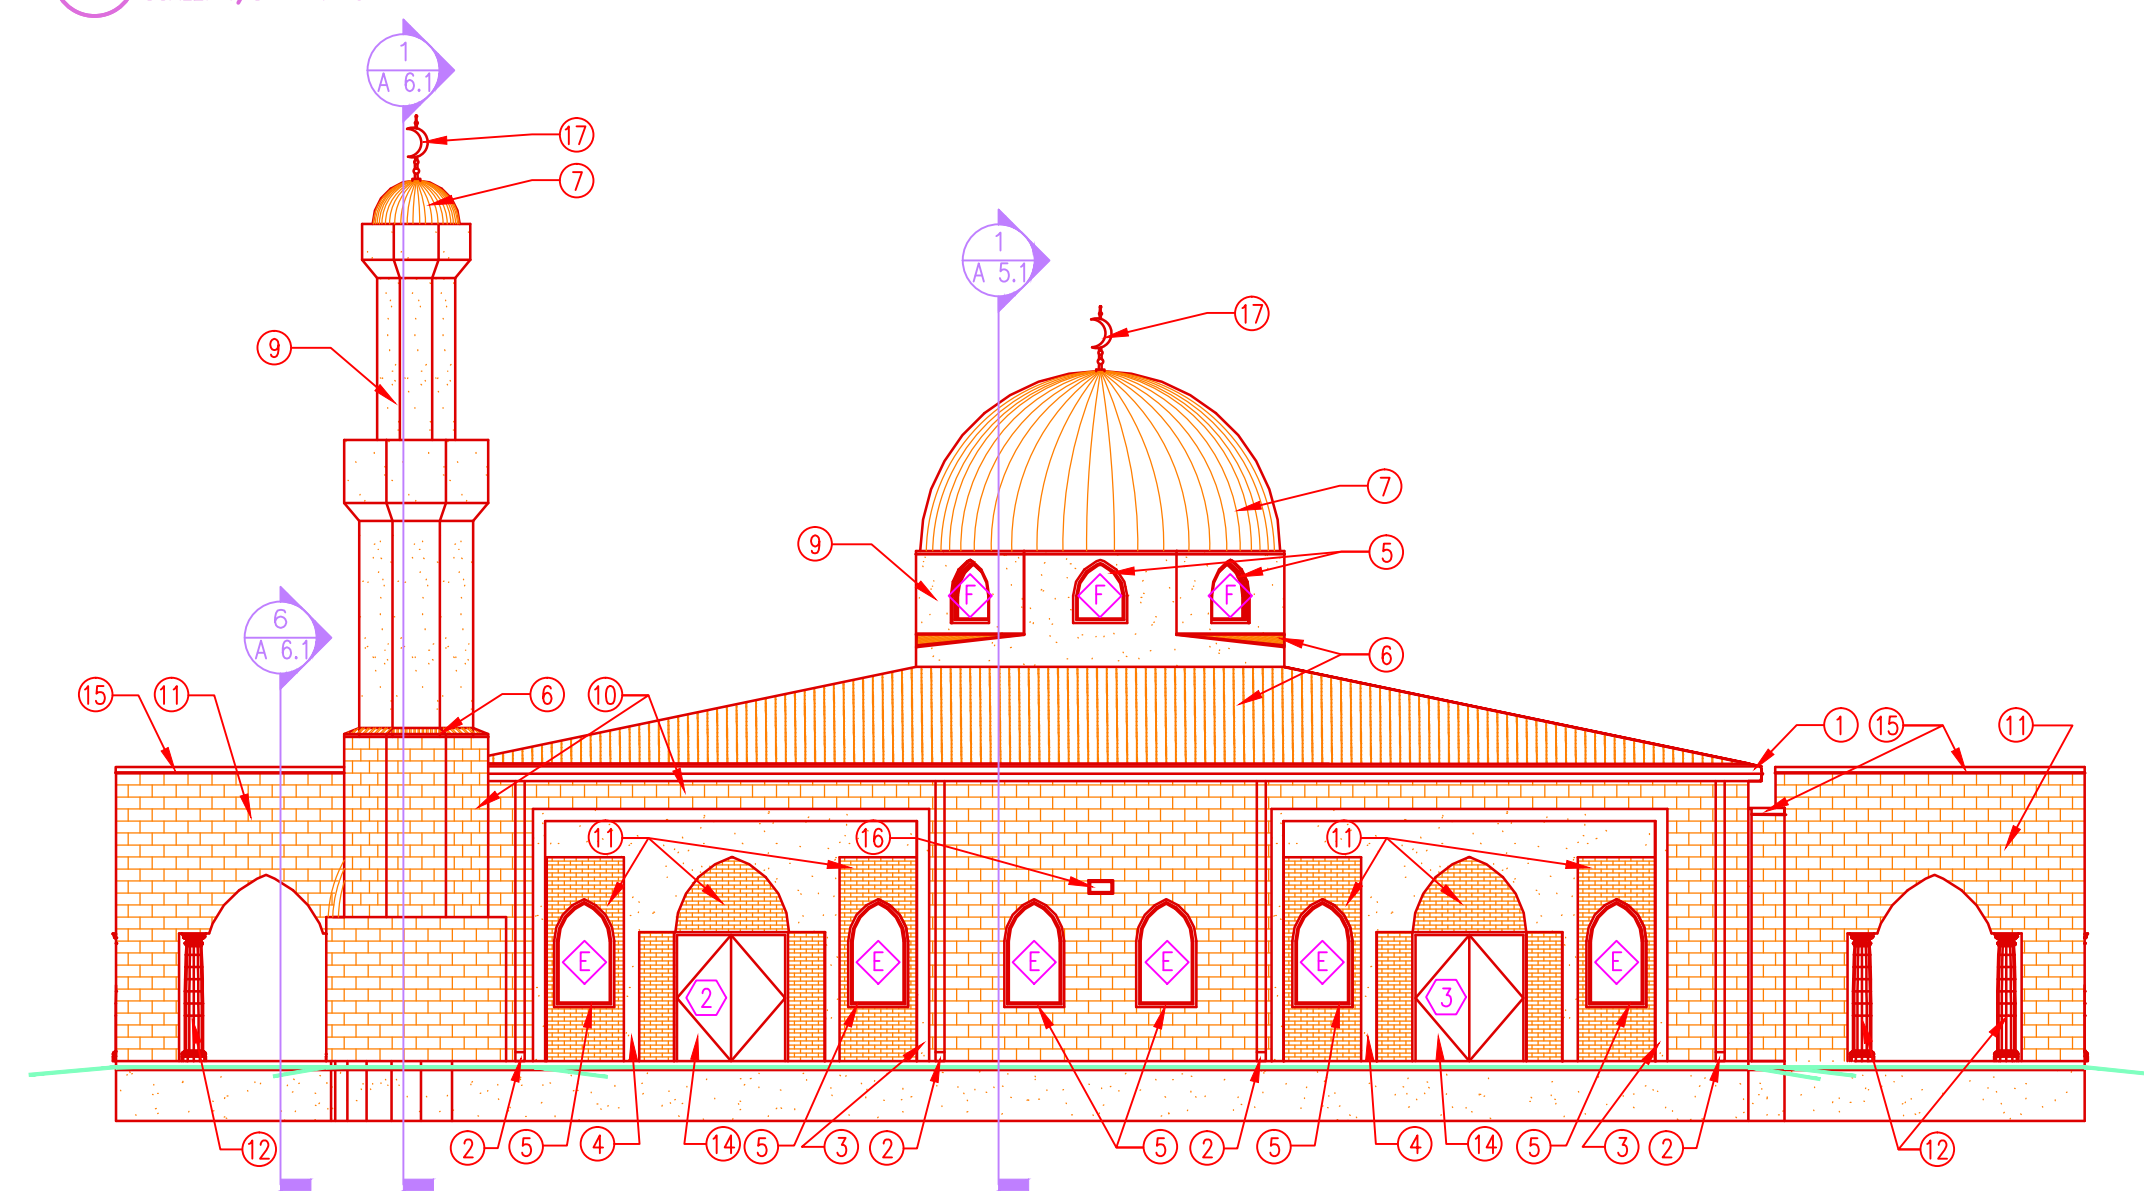

2 WEST ELEVATION
SCALE: 3/32" = 1'-0"

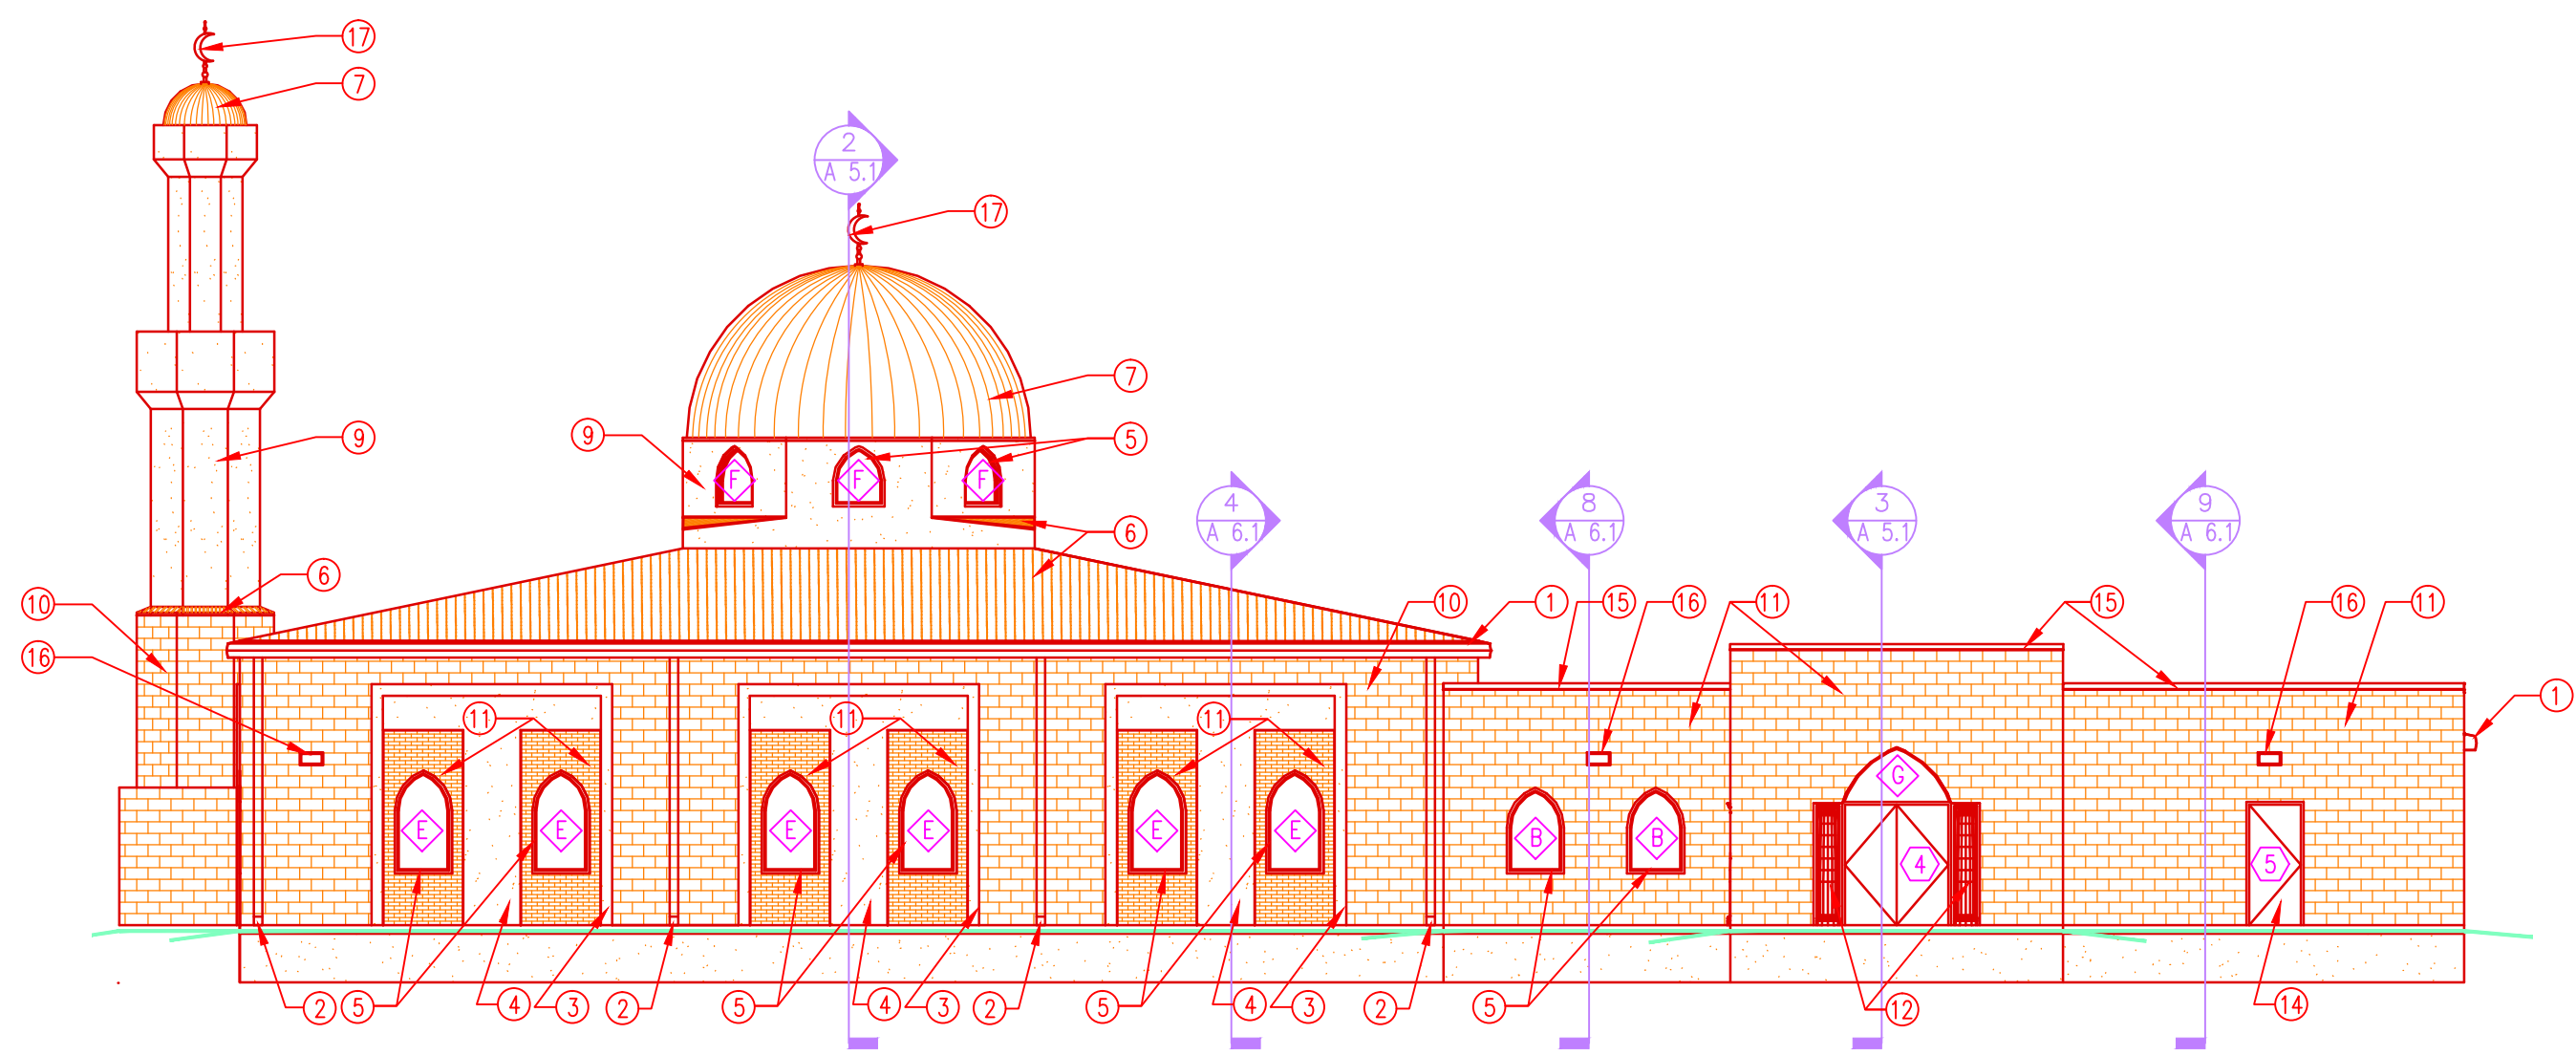

3 SOUTH ELEVATION
SCALE: 3/32" = 1'-0"

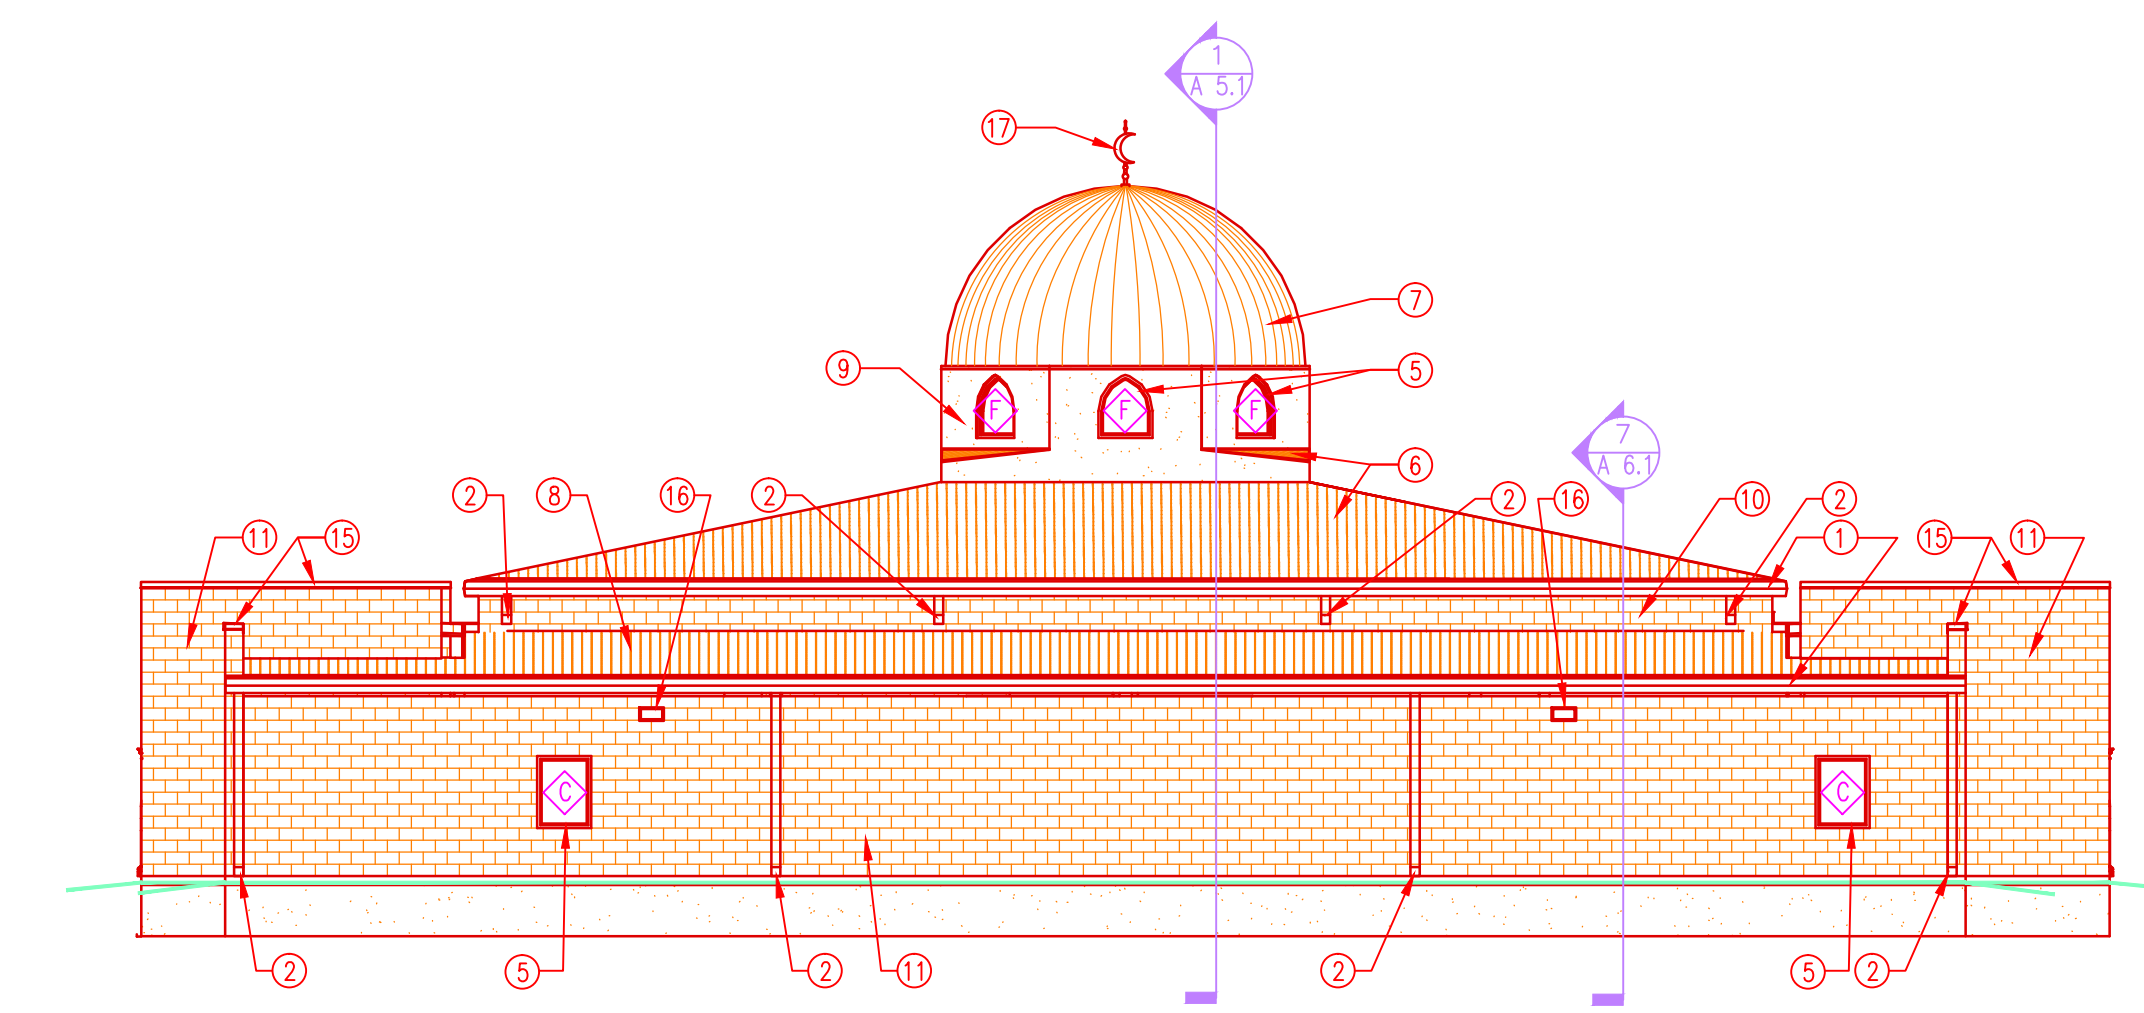

4 EAST ELEVATION
SCALE: 3/32" = 1'-0"

- ELEVATIONS CONSTRUCTION KEY NOTES**
- 8"x8" GUTTER (FINISH TO MATCH METAL ROOF PANELS)
 - 6"x6" DOWNSPOUT (FINISH TO MATCH METAL ROOF PANELS)
 - EFIS 1 X 8 TRIM OVER EFIS WALL SYSTEM
 - EFIS WALL SYSTEM OVER 4" SMOOTH FACE CMU VENEER
 - ALUMINUM WINDOW SYSTEM (IMPACTED RATED GLAZING AT CLERESTORY)
 - STANDING SEAM METAL ROOF SYSTEM BY METAL BLDG. MANUF.
 - PRE-FABRICATED FIBERGLASS REINFORCED LIGHTWEIGHT CONCRETE DOME
 - TPO ROOF MEMBRANE ON RIGID INSULATION OVER METAL ROOF DECK
 - EFIS WALL SYSTEM OVER WATERPROOF MEMBRANE & SHEATHING
 - 4" MASONRY VENEER (TYPE 1 MASONRY)
 - 4" ACCENT MASONRY VENEER (TYPE 2 MASONRY)
 - DECORATIVE PRE-CAST COLUMN COVERS (DORIC STYLE)
 - METAL RAIN GUARD (GALVANIZED, PRIMED, PTD.)
 - HOLLOW METAL DOOR AND FRAME (GALVANIZED, PRIMED, PTD.)
 - METAL CAP FLASHING (FINISH TO MATCH ROOF PANELS)
 - EXTERIOR LIGHT FIXTURE (REFER TO ELECTRICAL DWGS)
 - CRESCENT MOON FINIAL

- MASONRY SCHEDULE**
- TYPE 1 MASONRY - ACME SOUTH TEXAS BLEND CHOPPED
 - TYPE 2 MASONRY - HILL COUNTRY STONE BY FEATHERLITE (CHARCOAL)

- EXTERIOR EFIS SCHEDULE**
- EFIS WALL SURFACE - TEFIS PAREX COLOR (OYSTER T010L - 57)
 - EFIS TRIM SURFACE - TEFIS PAREX COLOR (SANTIAGO 3032L - 19)

- STANDING SEAM METAL ROOF PANEL SCHEDULE**
- METAL PANEL COLOR - BERRIDGE STANDARD COLOR - FOREST GREEN

- ELEVATION GENERAL NOTES**
- CONTRACTOR TO VERIFY ALL DIMENSIONS BOTH NEW AND EXISTING PRIOR TO COMMENCING WORK. COORDINATE WITH STRUCTURAL AND METAL BUILDING MANUFACTURER.
 - REFER TO CIVIL DRAWINGS FOR ROUGH AND FINISH ELEVATIONS.
 - CONTRACTOR TO PROVIDE MOCK-UP EFIS WALL PANELS FOR APPROVAL BY OWNER AND ARCHITECT.
 - EFIS BELOW 7'-0" AFF SHALL HAVE "PANZER MESH" FOR IMPACT RESISTANCE AND DURABILITY.

Terry K. Orf, AIA
Tx. License 13553
NOT FOR REGULATORY
APPROVAL PERMITTING
OR CONSTRUCTION

Project Title:
Mosque: Islamic Society of South Texas
7341 McARDLE ROAD
Corpus Christi, Texas 78412
Sheet Title:
EXTERIOR ELEVATIONS

Drawn by: _____ TKO
Approved by: _____ AS NOTED
Scale: _____ AS NOTED
Date: _____ 10/31/15
CAD File: _____
Project No.: _____ 2015-009

Sheet Number:
A-4.1

ArchitectTKO
3300 E. Braselley Avenue
Arling Park, Texas 78246
Phone: 361.946.9999
Fax: 361.946.9999
www.architecttko.com

I, ARCHITECT, HEREBY CERTIFY THAT I AM THE DESIGNER OF RECORD FOR THE PROJECT AND I HAVE PREPARED OR CAUSED TO BE PREPARED THE ARCHITECTURAL DRAWINGS AND SPECIFICATIONS FOR THE PROJECT. I AM NOT PROVIDING THESE DRAWINGS TO ANY OTHER PARTY WITHOUT THE WRITTEN CONSENT OF ARCHITECTTKO. ANY REVISIONS TO THESE DRAWINGS SHALL BE MADE BY ARCHITECTTKO. I AM NOT PROVIDING THESE DRAWINGS TO ANY OTHER PARTY WITHOUT THE WRITTEN CONSENT OF ARCHITECTTKO. ANY REVISIONS TO THESE DRAWINGS SHALL BE MADE BY ARCHITECTTKO.